



- LEGEND:**
- ⊕ - DUPLEX RECEPTACLE, 125V, 20AMP; COLOR, STYLE AND FACEPLATE BY OWNER
 - ⊖ - DUPLEX RECEPTACLE, 125V, 20AMP; WEATHER PROOF; COLOR, STYLE AND FACEPLATE BY OWNER
 - ⊖ - DRGR. RECEPTACLE, 250V, 30AMP; COLOR, STYLE AND FACEPLATE BY OWNER

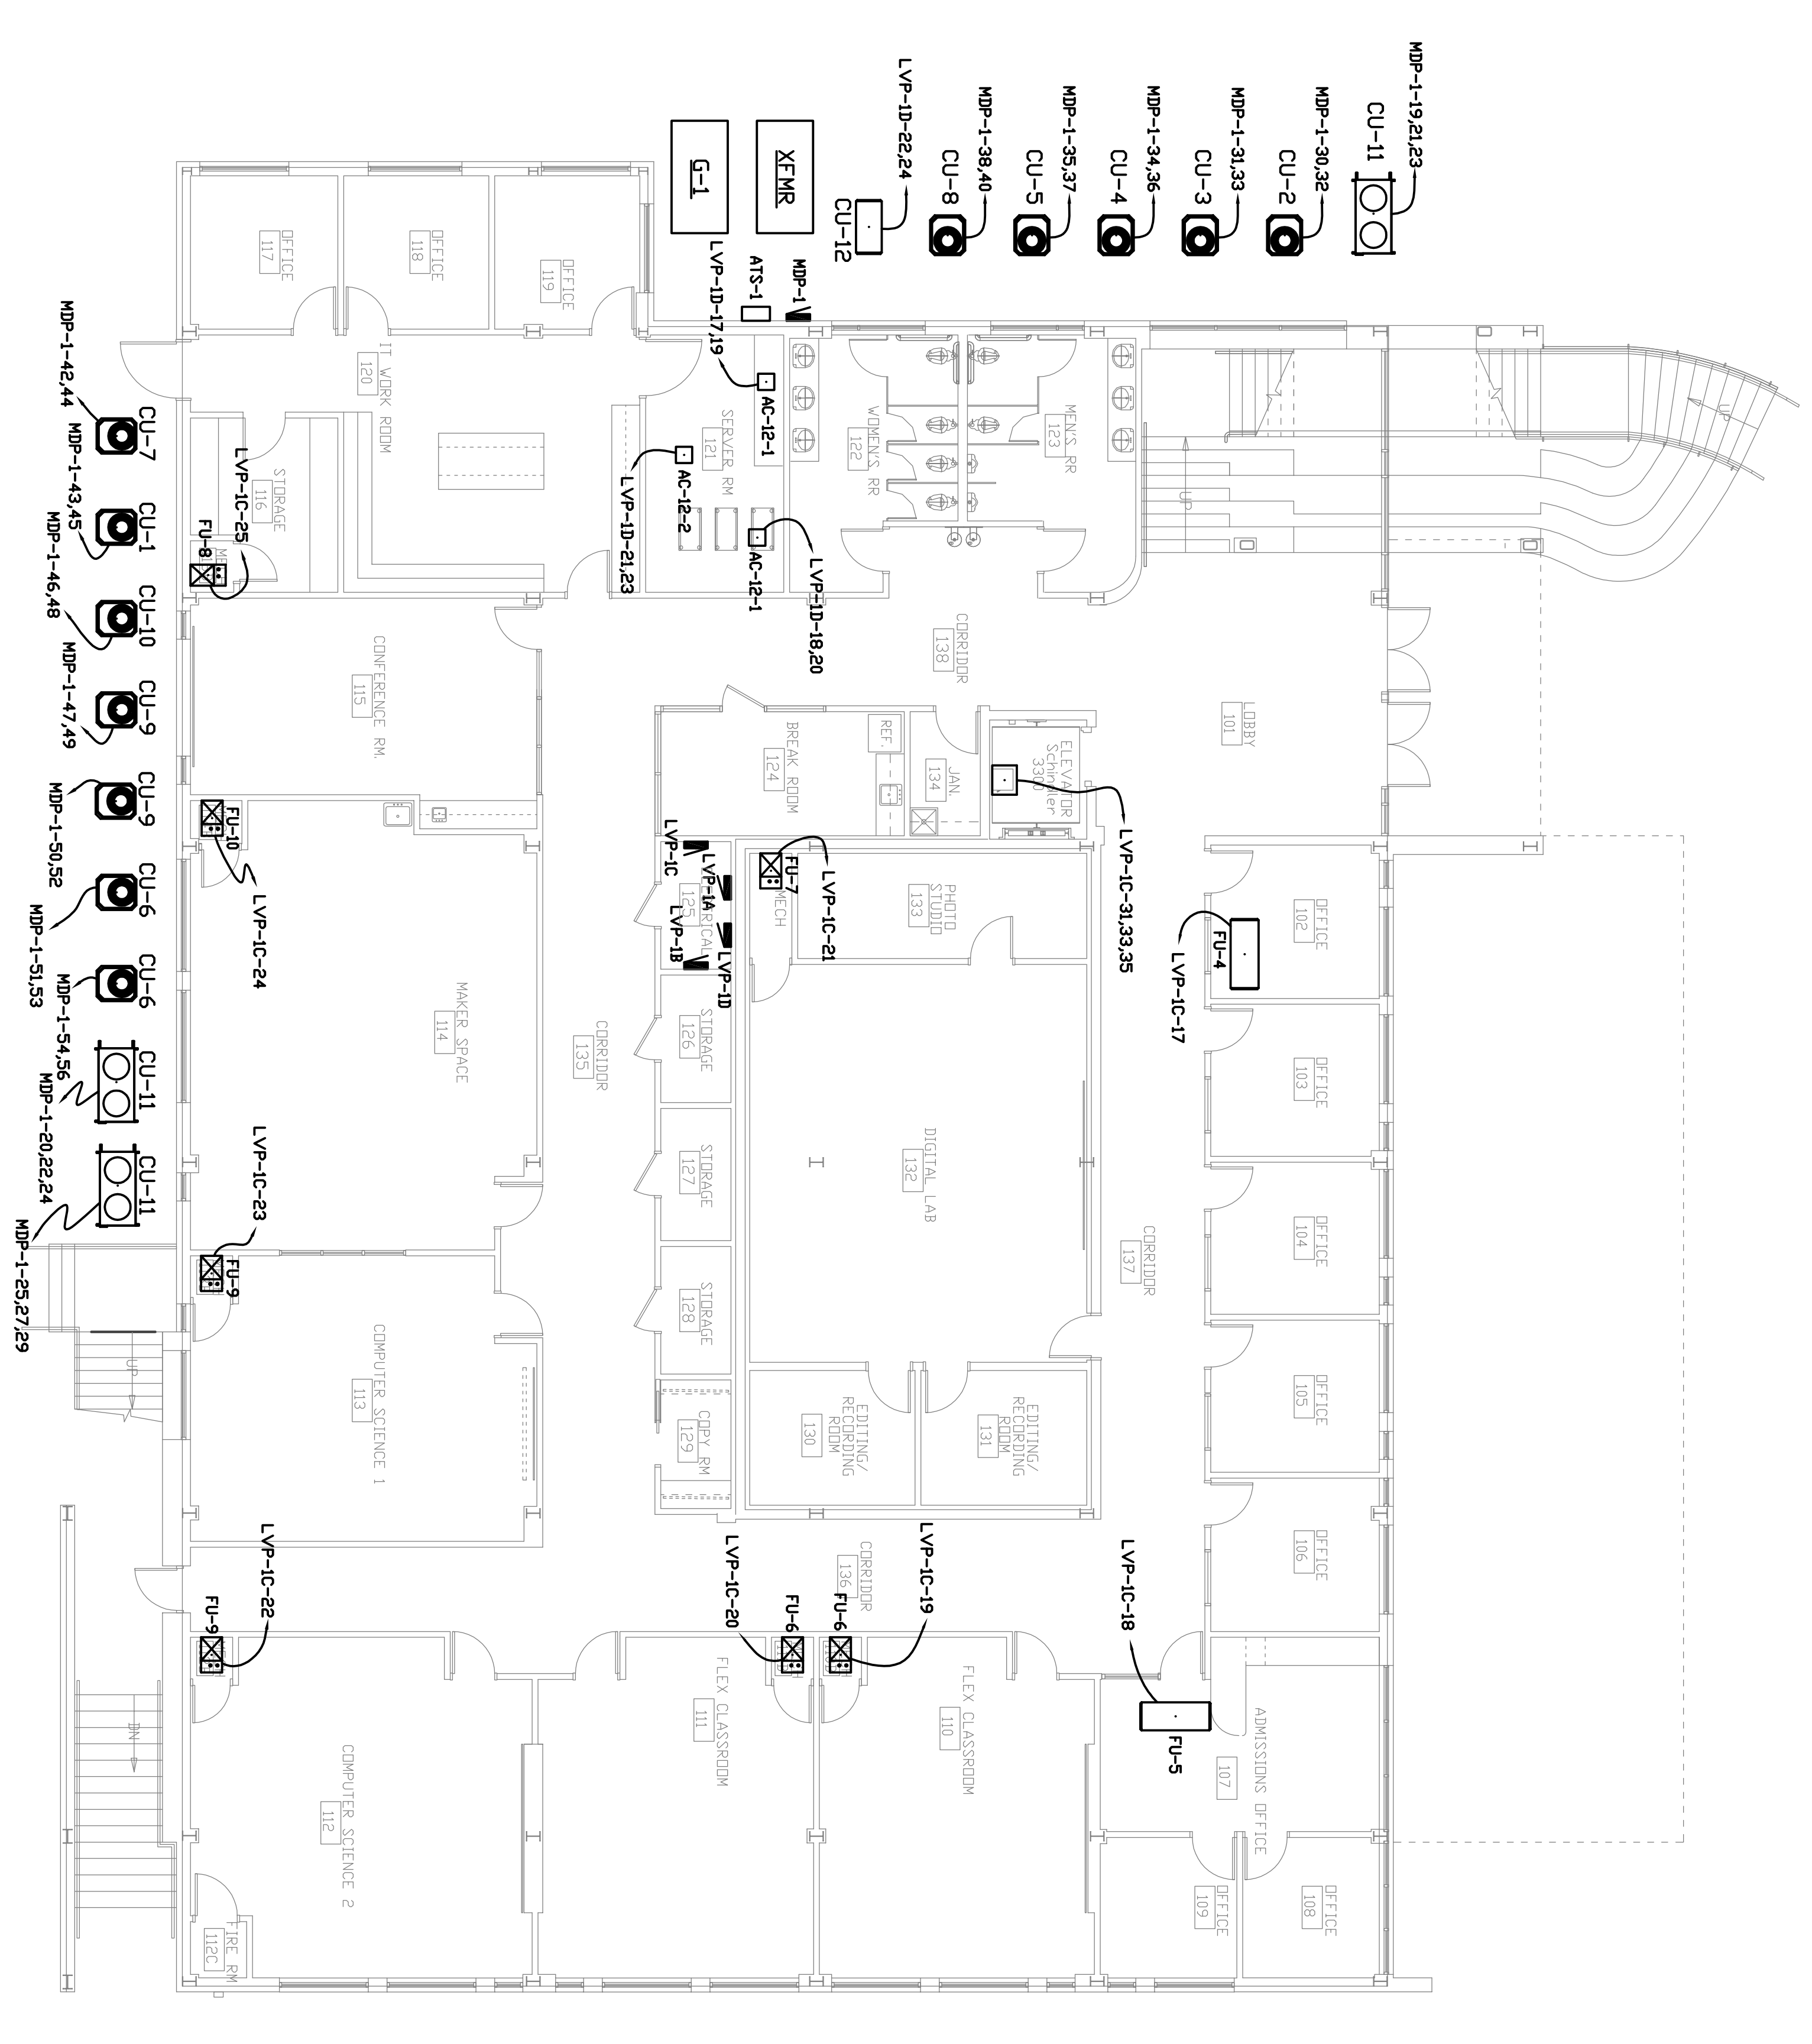

N
FIRST FLOOR HVAC/POWER PLAN
1/8" = 1'-0"

CREATIVITY AND INNOVATION COMPLEX
 Arkansas School for Mathematics, Sciences, and the Arts
 200 Whittington Avenue, Hot Springs National Park, AR 71901

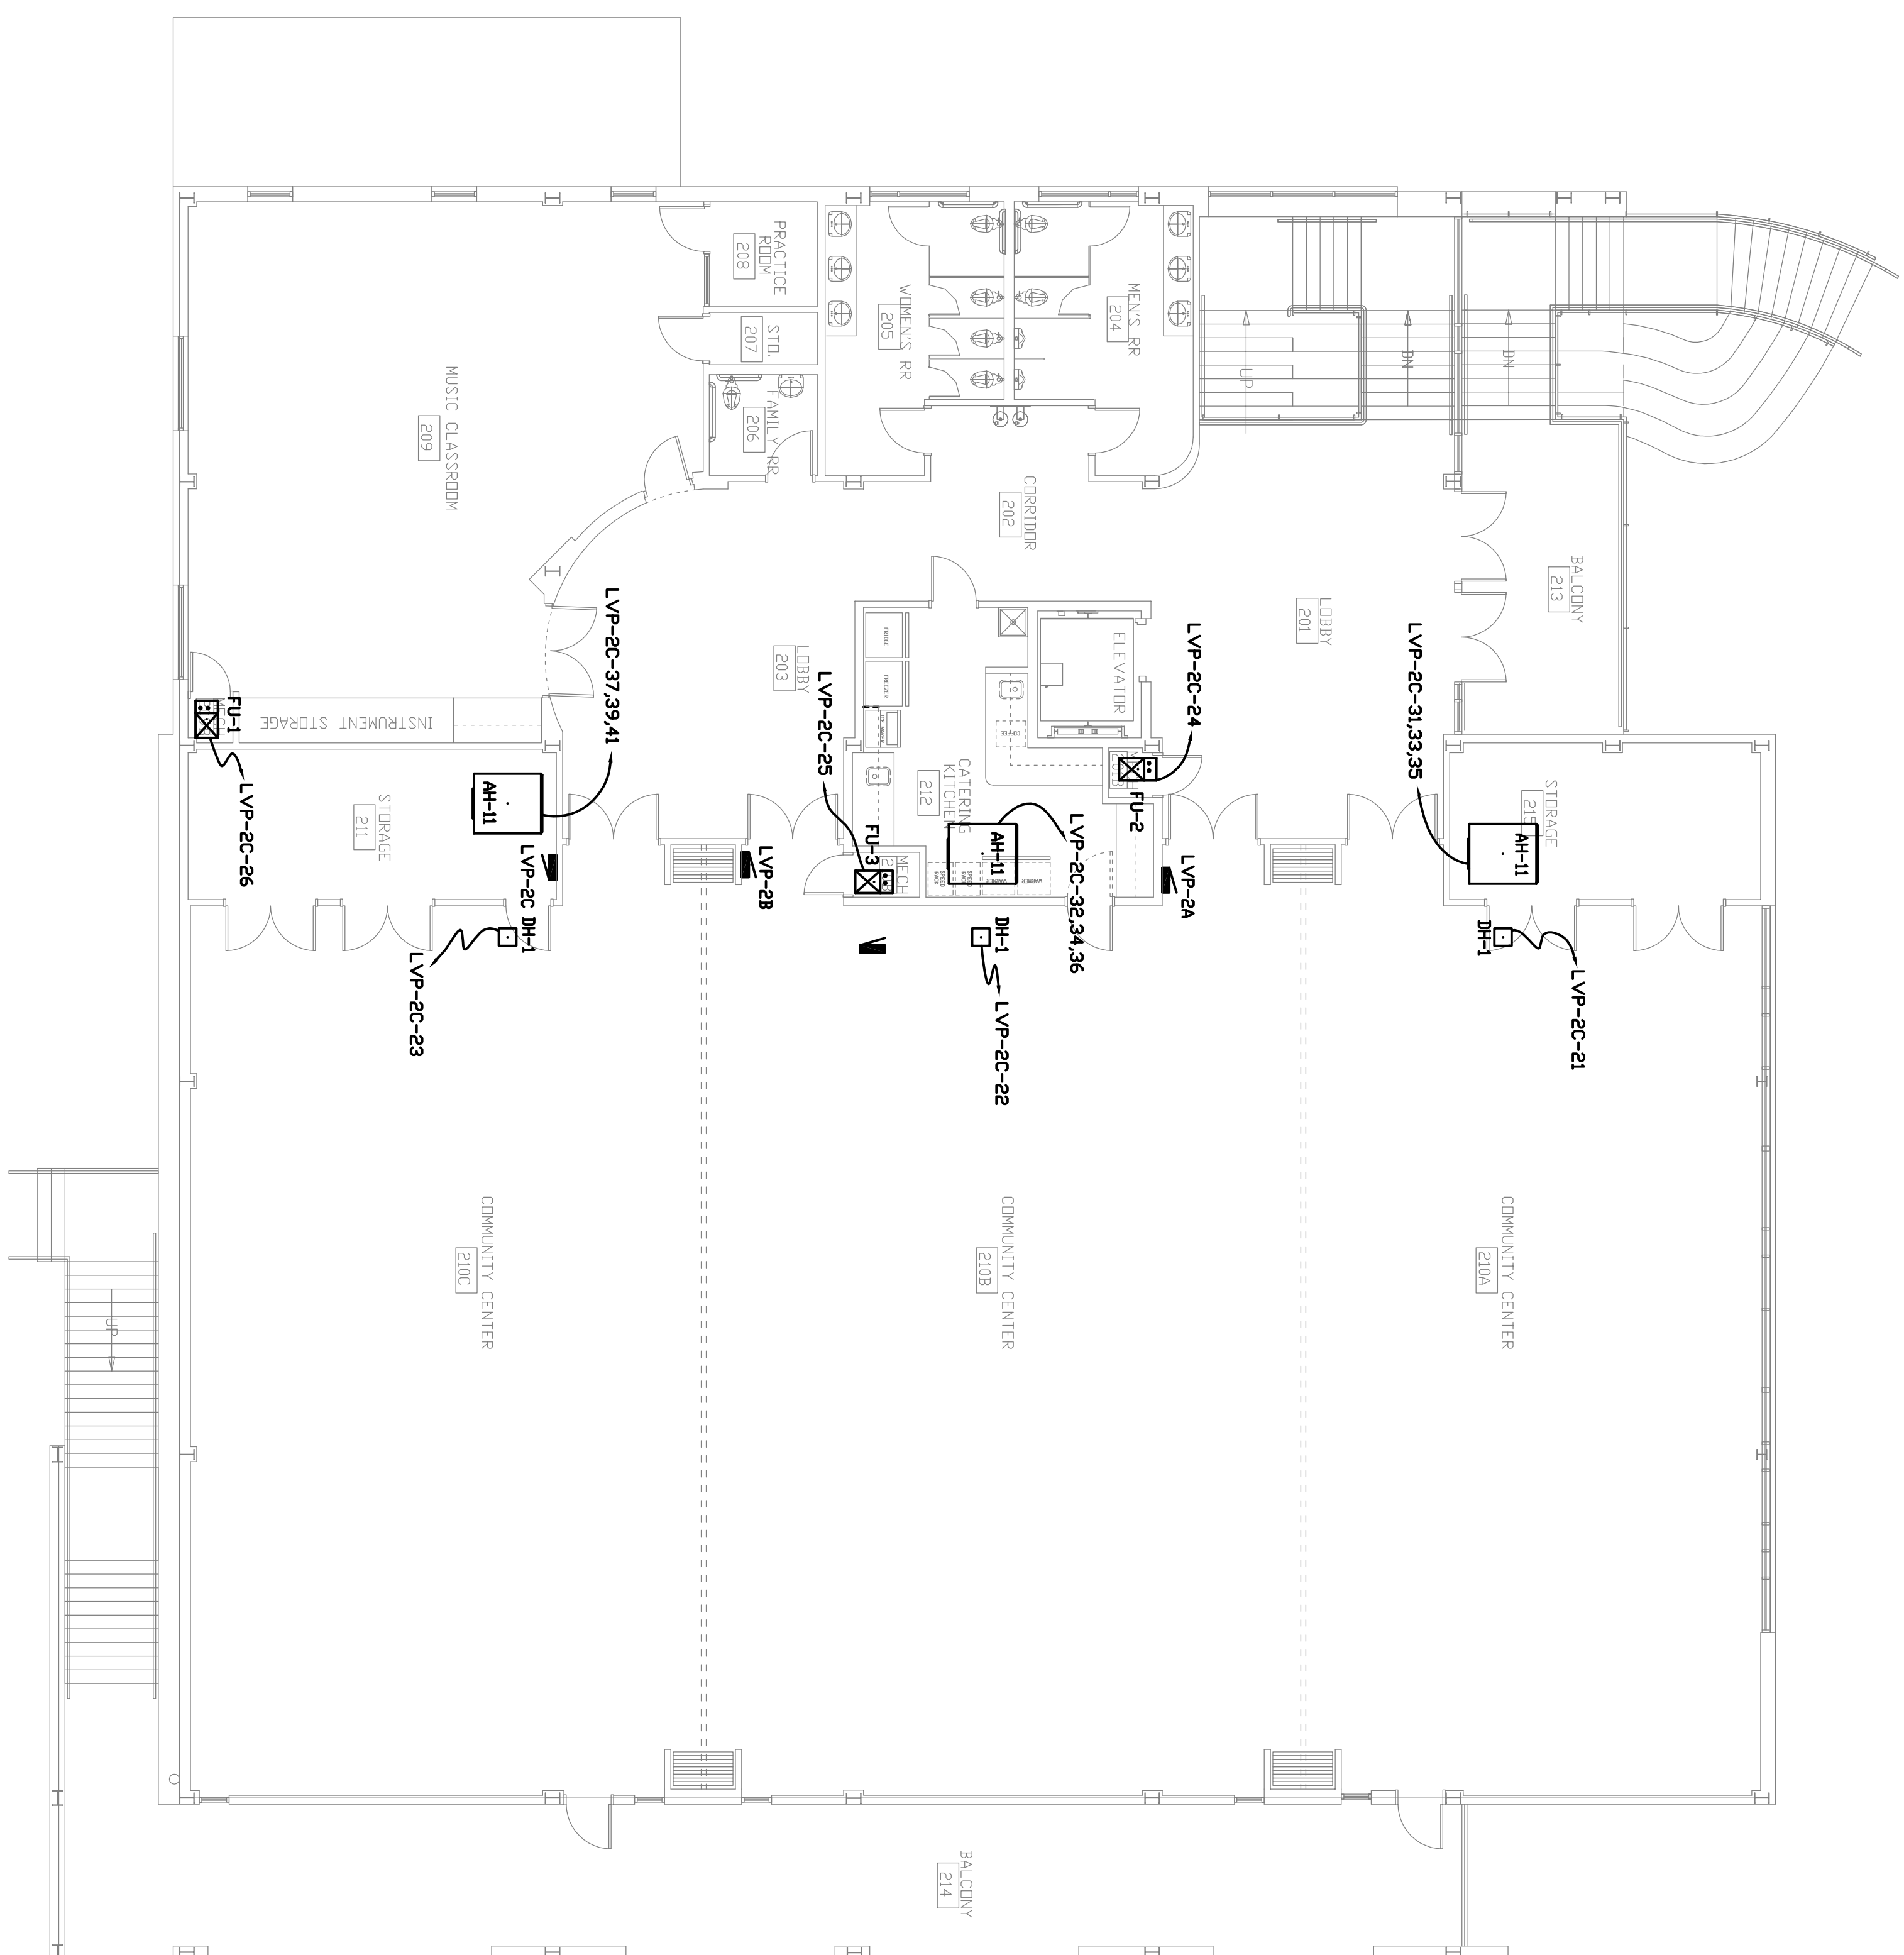

- LEGEND:**
- ⊕ - DUPLEX RECEPTACLE, 125V, 20AMP, COLOR, STYLE AND FACEPLATE BY OWNER
 - ⊖ - DUPLEX RECEPTACLE, 125V, 20AMP, WEATHER PROOF, COLOR, STYLE AND FACEPLATE BY OWNER
 - ⊙ - OTHER RECEPTACLE, 250V, 30AMP, COLOR, STYLE AND FACEPLATE BY OWNER

N
 1/8" = 1'-0"
 SECOND FLOOR HVAC/POWER PLAN

CREATIVITY AND INNOVATION COMPLEX
 Arkansas School for Mathematics, Sciences, and the Arts
 200 Whittington Avenue, Hot Springs National Park, AR 71901